


1 MCC-7 - ONE-LINE DIAGRAM
SCALE: NONE

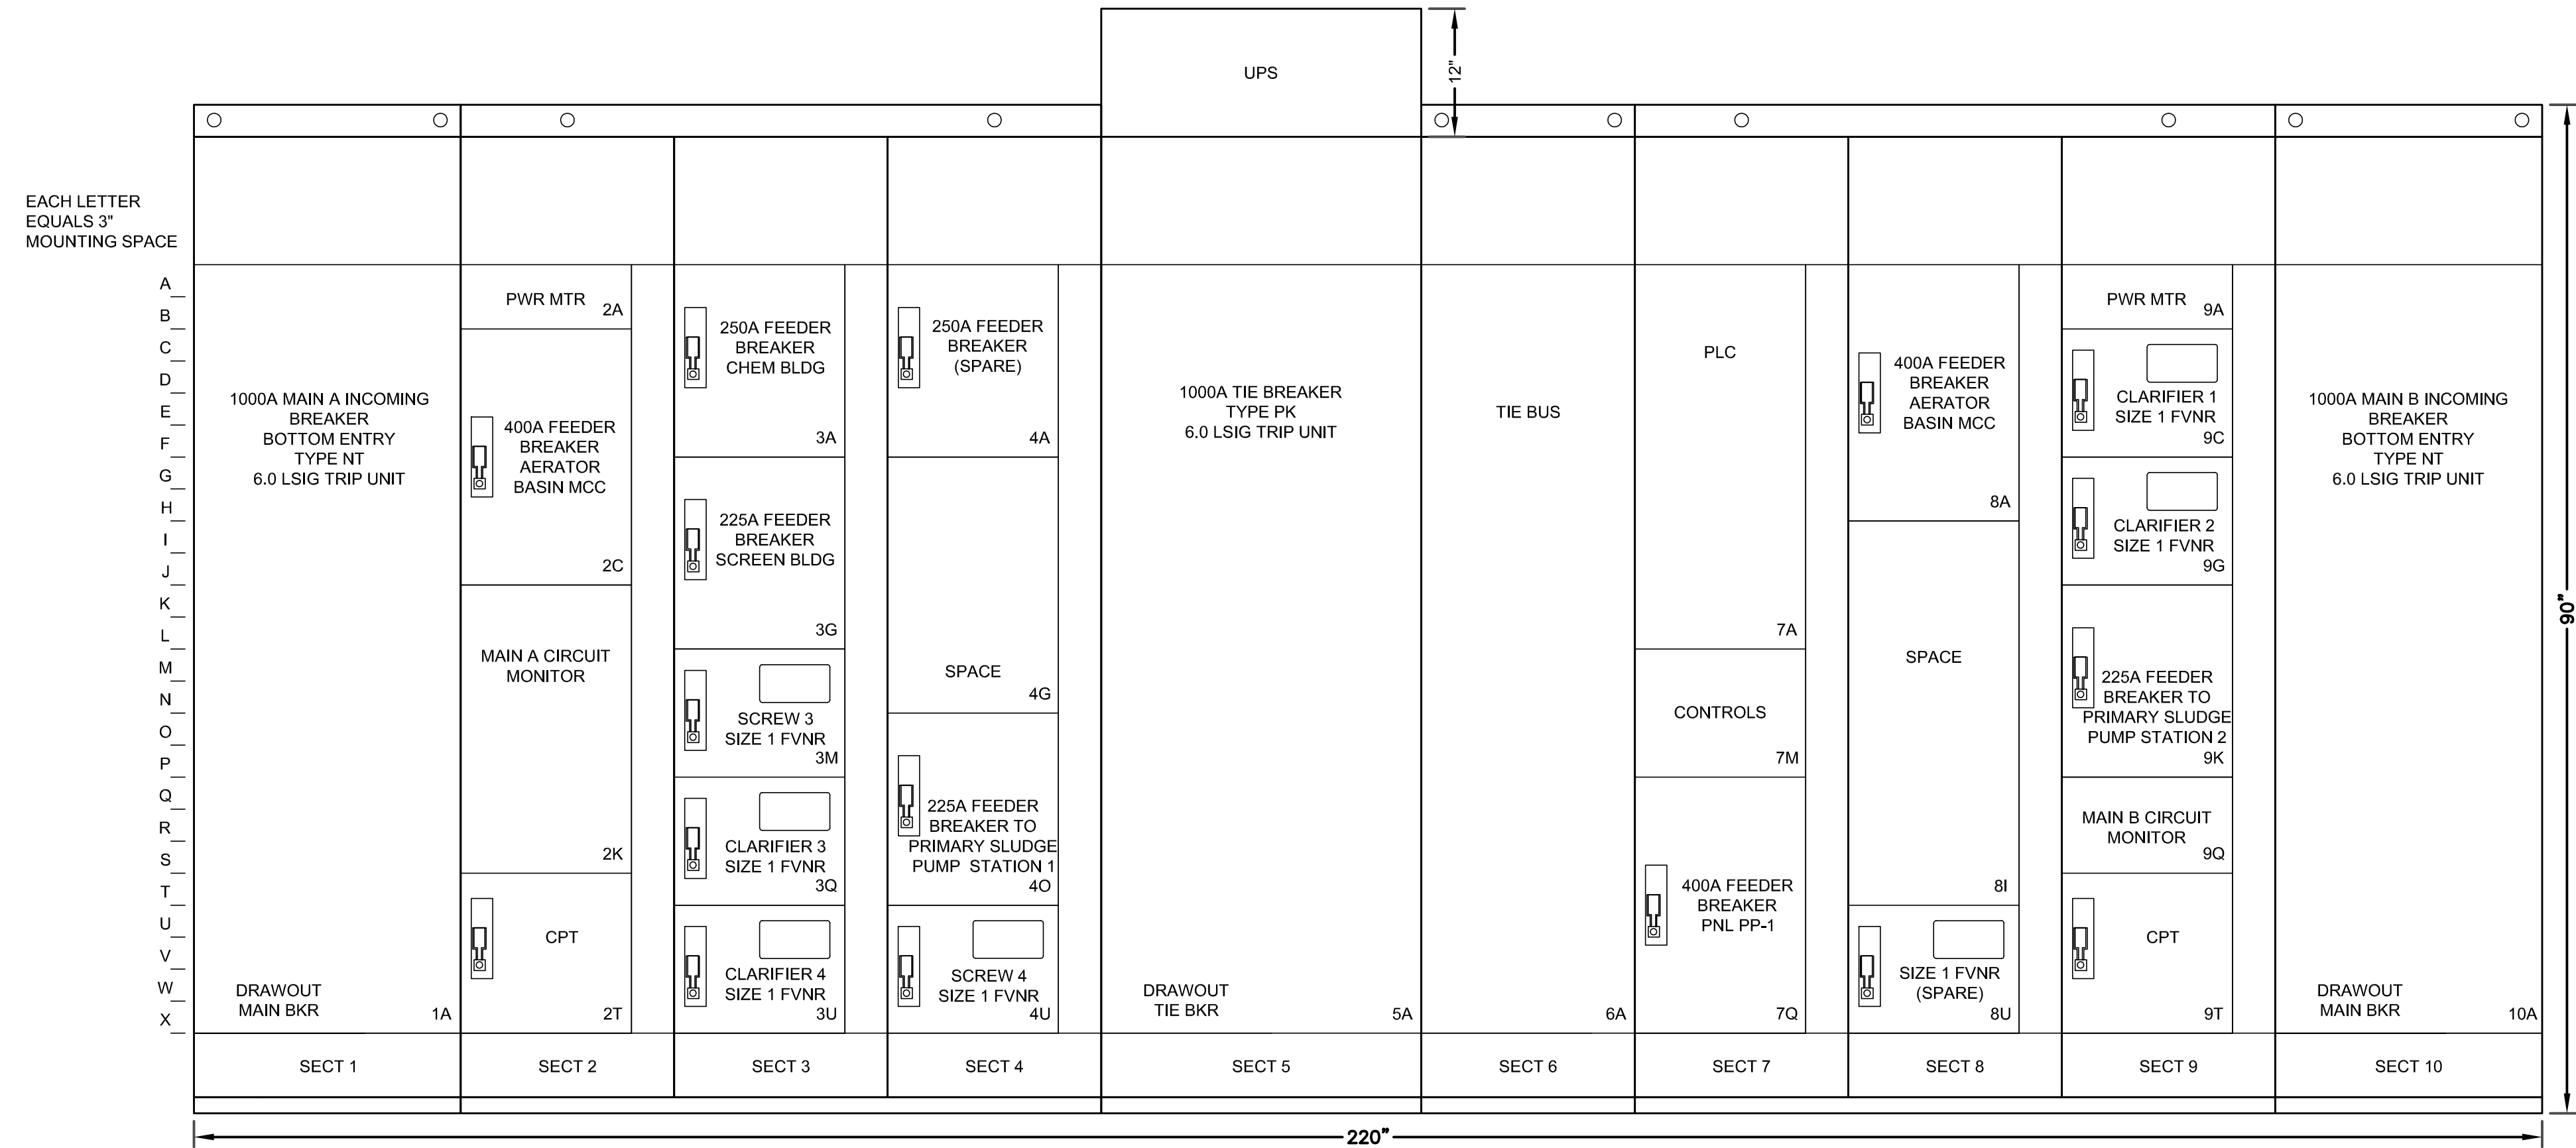

2 MCC-7 - MCC ELEVATION
SCALE: NONE

GENERAL NOTES:

- MCC NEUTRAL BUS IS CONTINUOUS THROUGH ALL SECTIONS. INSTALL A SINGLE NEUTRAL-GROUND BOND FOR THE ENTIRE MCC SECTION.
- COORDINATE REMOVAL AND RECONNECTION OF ELECTRICAL SERVICE WITH SVEC.
- ALL LOADS FED OUT OF MCC-7 ARE EXISTING AND ARE CURRENTLY FED OUT OF THE EXISTING MCC LOCATED IN BUILDING 1. LOADS SHALL REMAIN IN OPERATION THROUGHOUT THE DURATION OF CONSTRUCTION. REFER TO SHEET E-001, PERMISSIBLE EQUIPMENT OUTAGE TABLE, FOR MAXIMUM TIME PERMITTED FOR OUTAGES TO EACH LOAD.



NOT FOR CONSTRUCTION

HARRISONBURG ROCKINGHAM REGIONAL SERVICE AUTHORITY
ELECTRICAL BUILDING 1

ROCKINGHAM COUNTY, VA

REVISION DESCRIPTION

COMM NO:	219207
DATE:	02/26/2020
DRAWN:	RSE
DESIGN:	GSF
CHECK:	MSA
SHEET TITLE	
MCC-7 ONE-LINE DIAGRAM & MCC ELEVATION	
SHT. NO.	E-201
REV. NO.	0

12/26/2013 6:33 AM X:\2019\219207 HRRSA TO62 Elect Bldg\CAD\Elec\219207_E-701.dwg