




X:\2014\214113 HRRSA18 VRLF APPLICATION SUPPORT\CAD V2013\CIVIL\214113CSK01.DWG 12/11/2014 9:06 AM

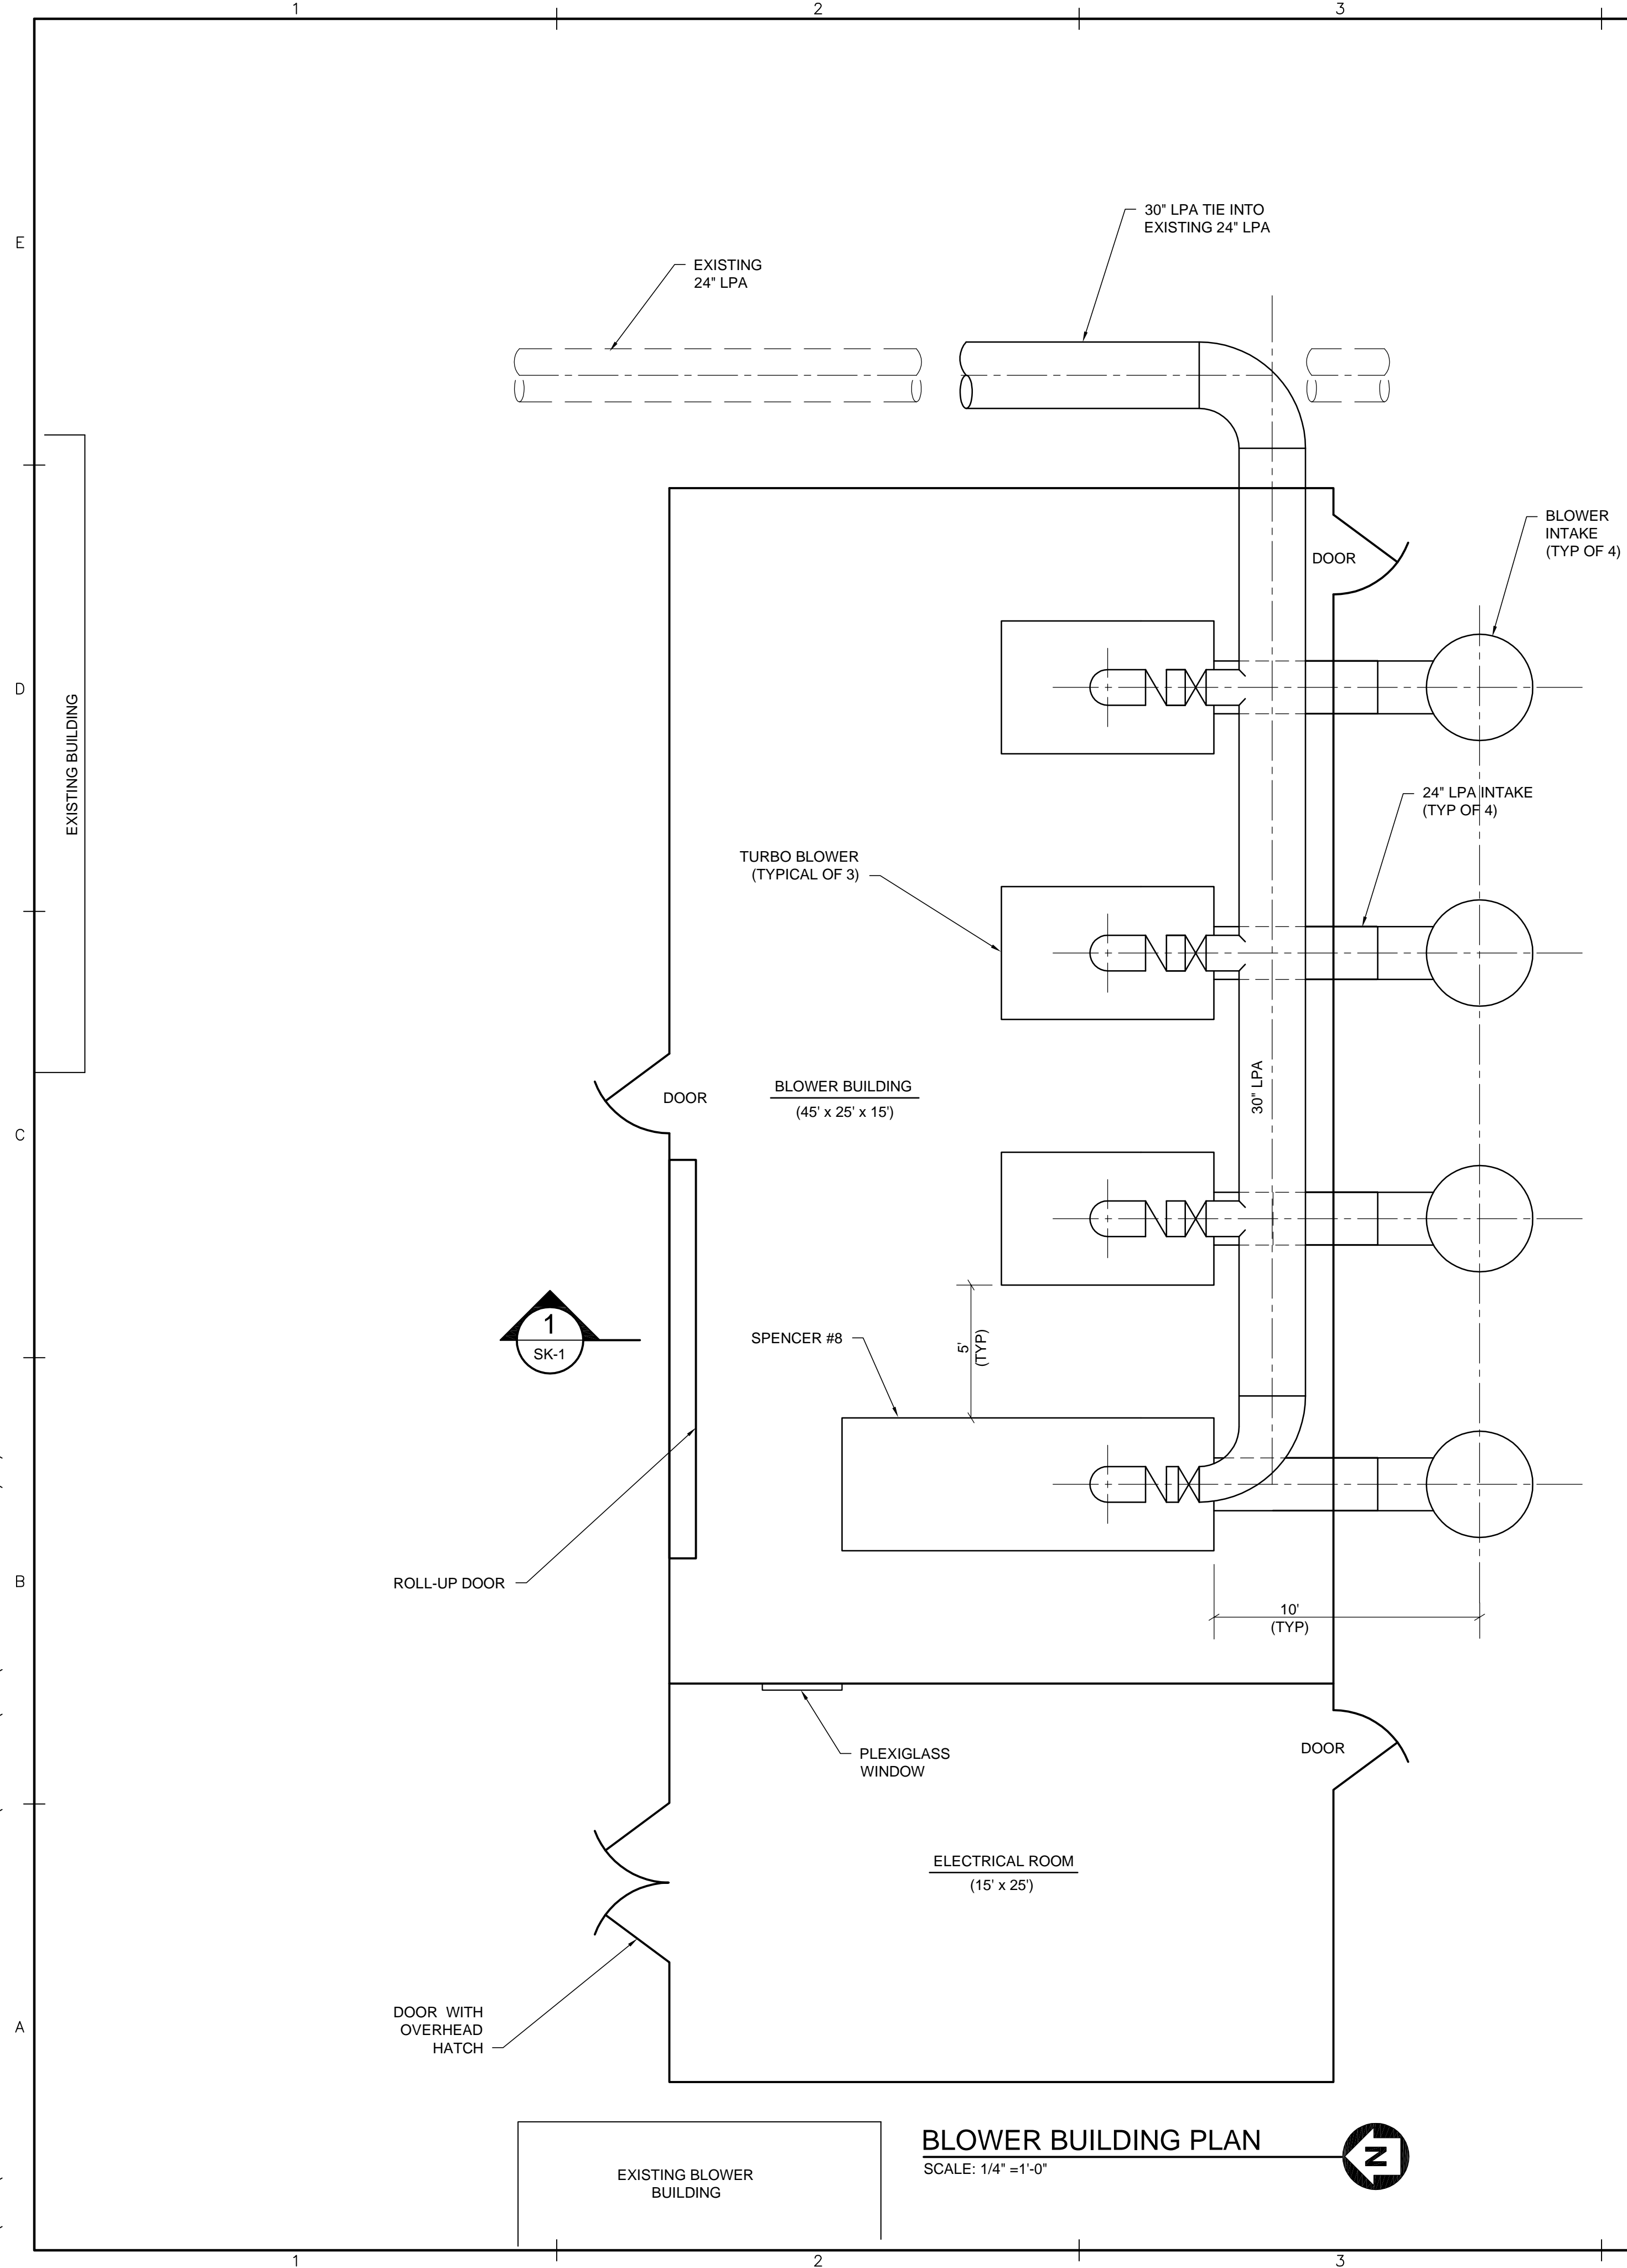

BLOWER BUILDING PLAN
SCALE: 1/4" = 1'-0"

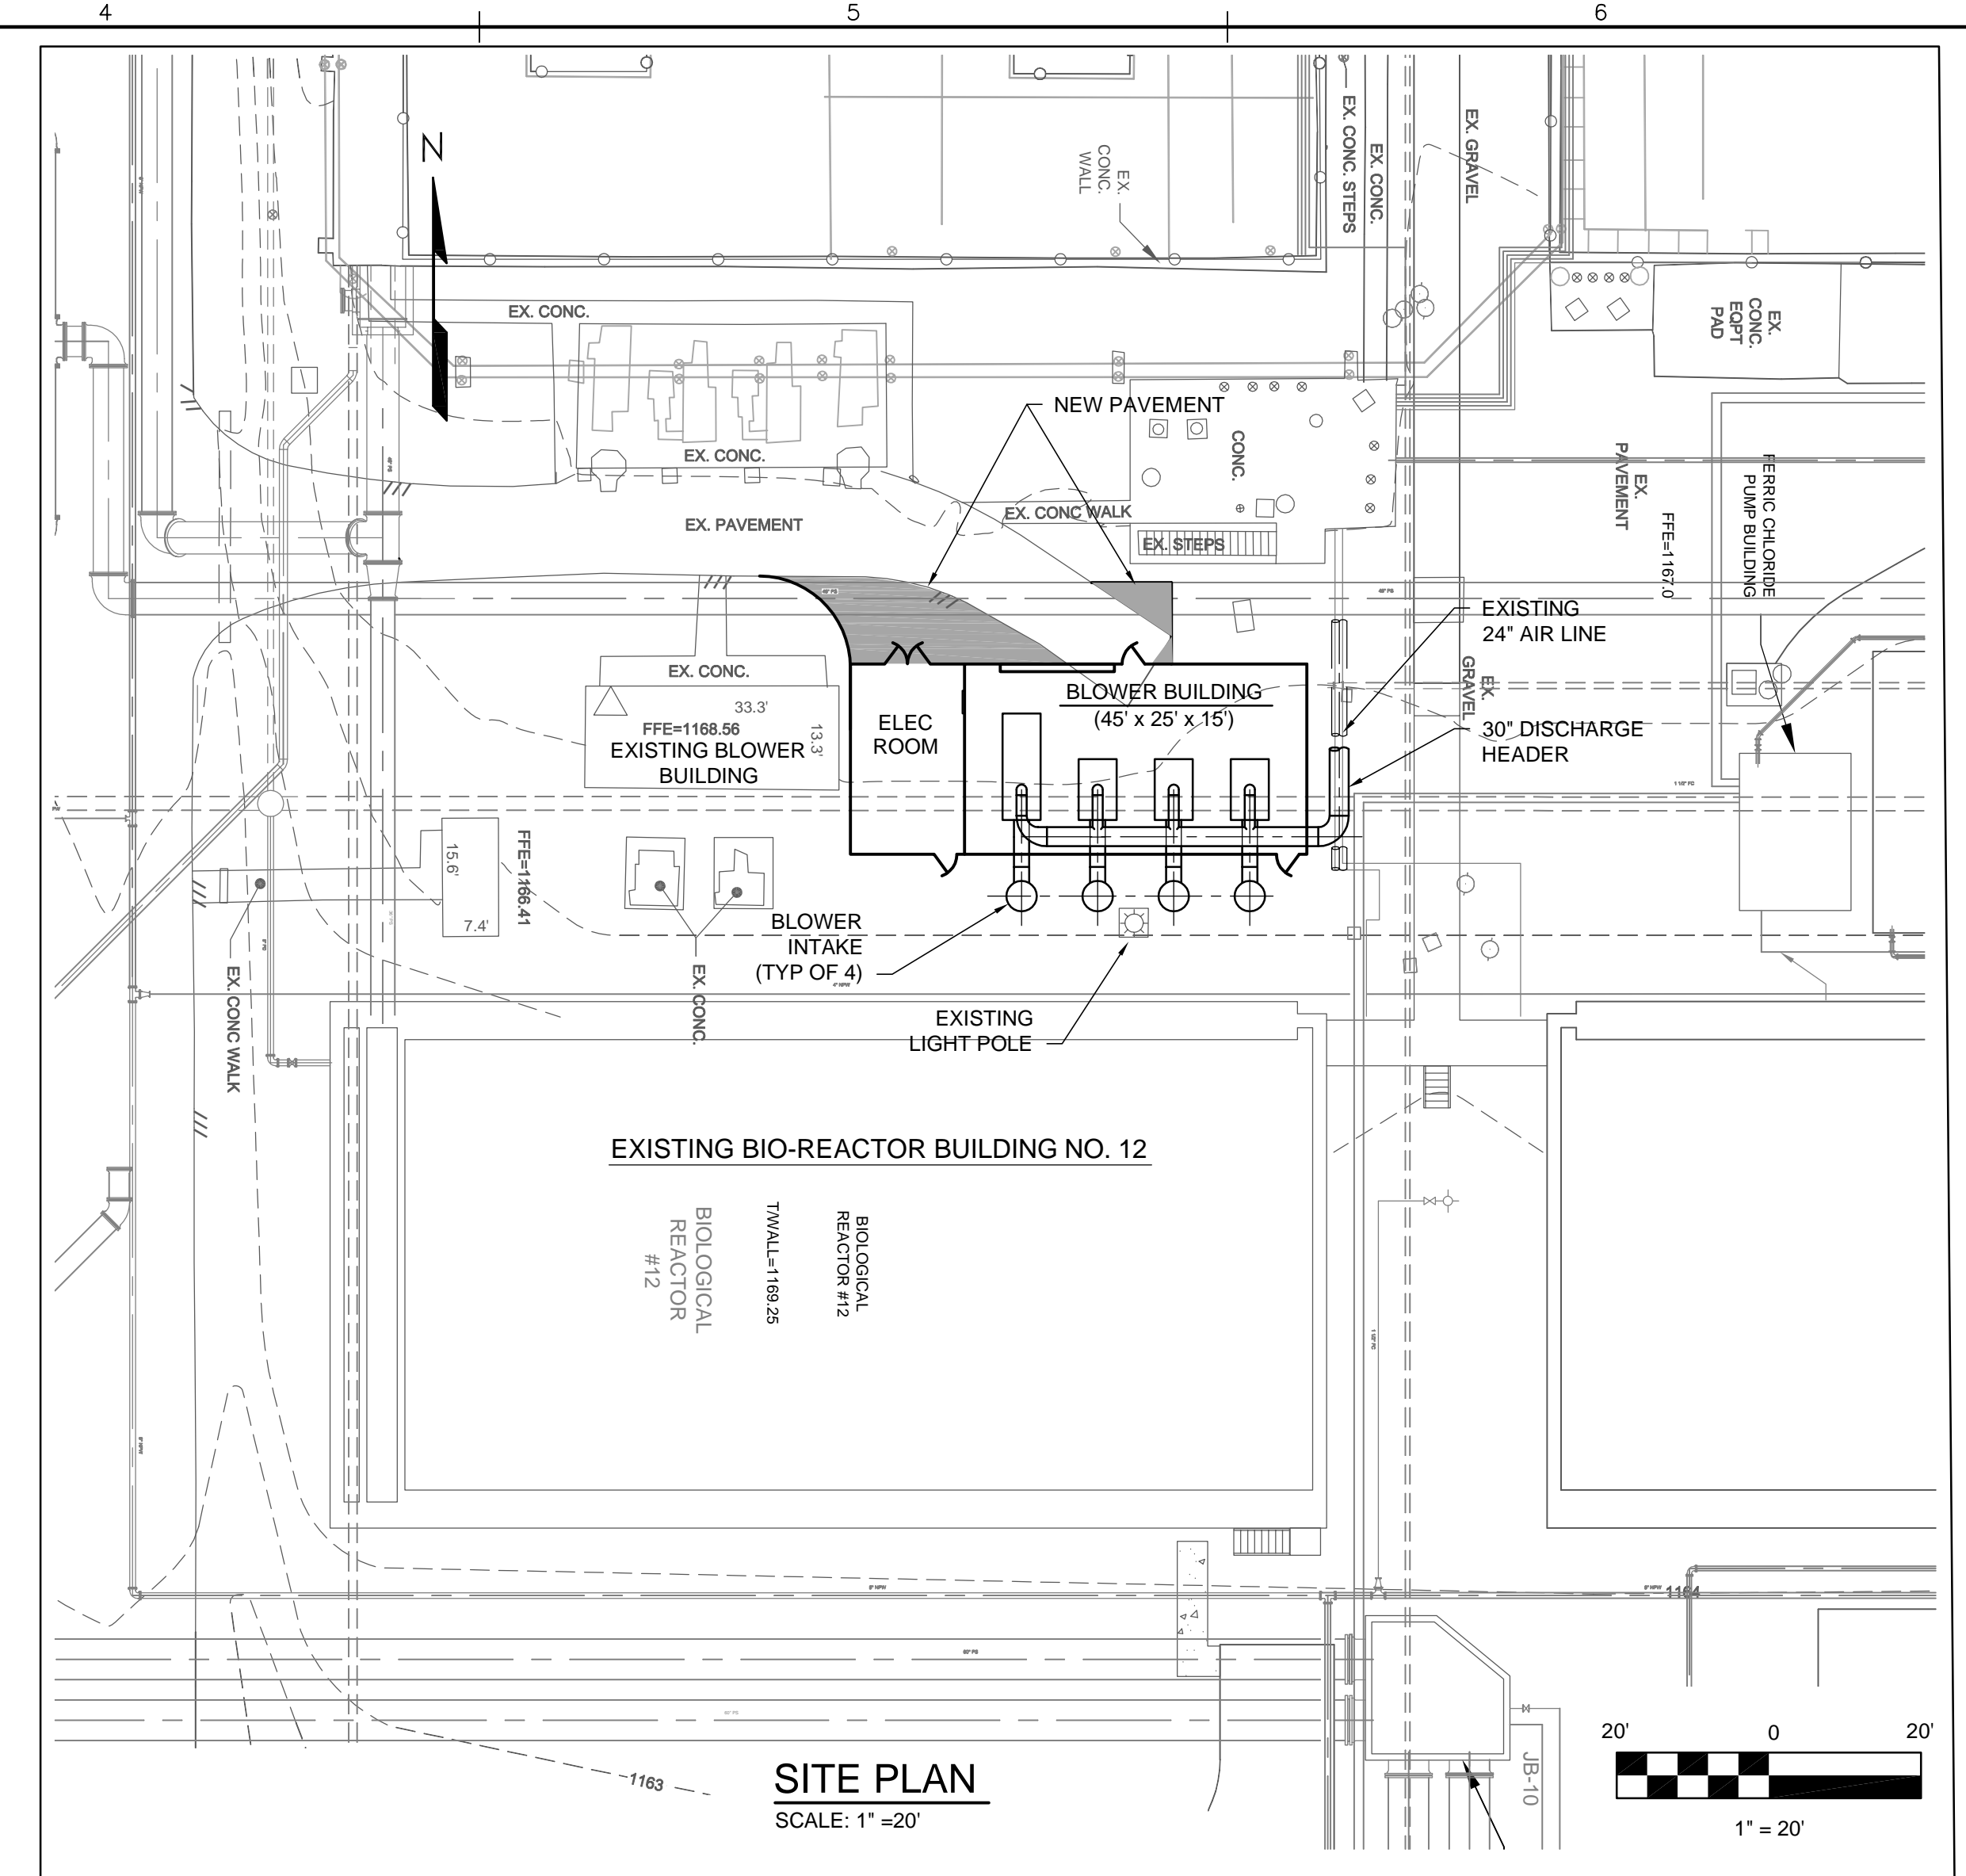

SITE PLAN
SCALE: 1" = 20"

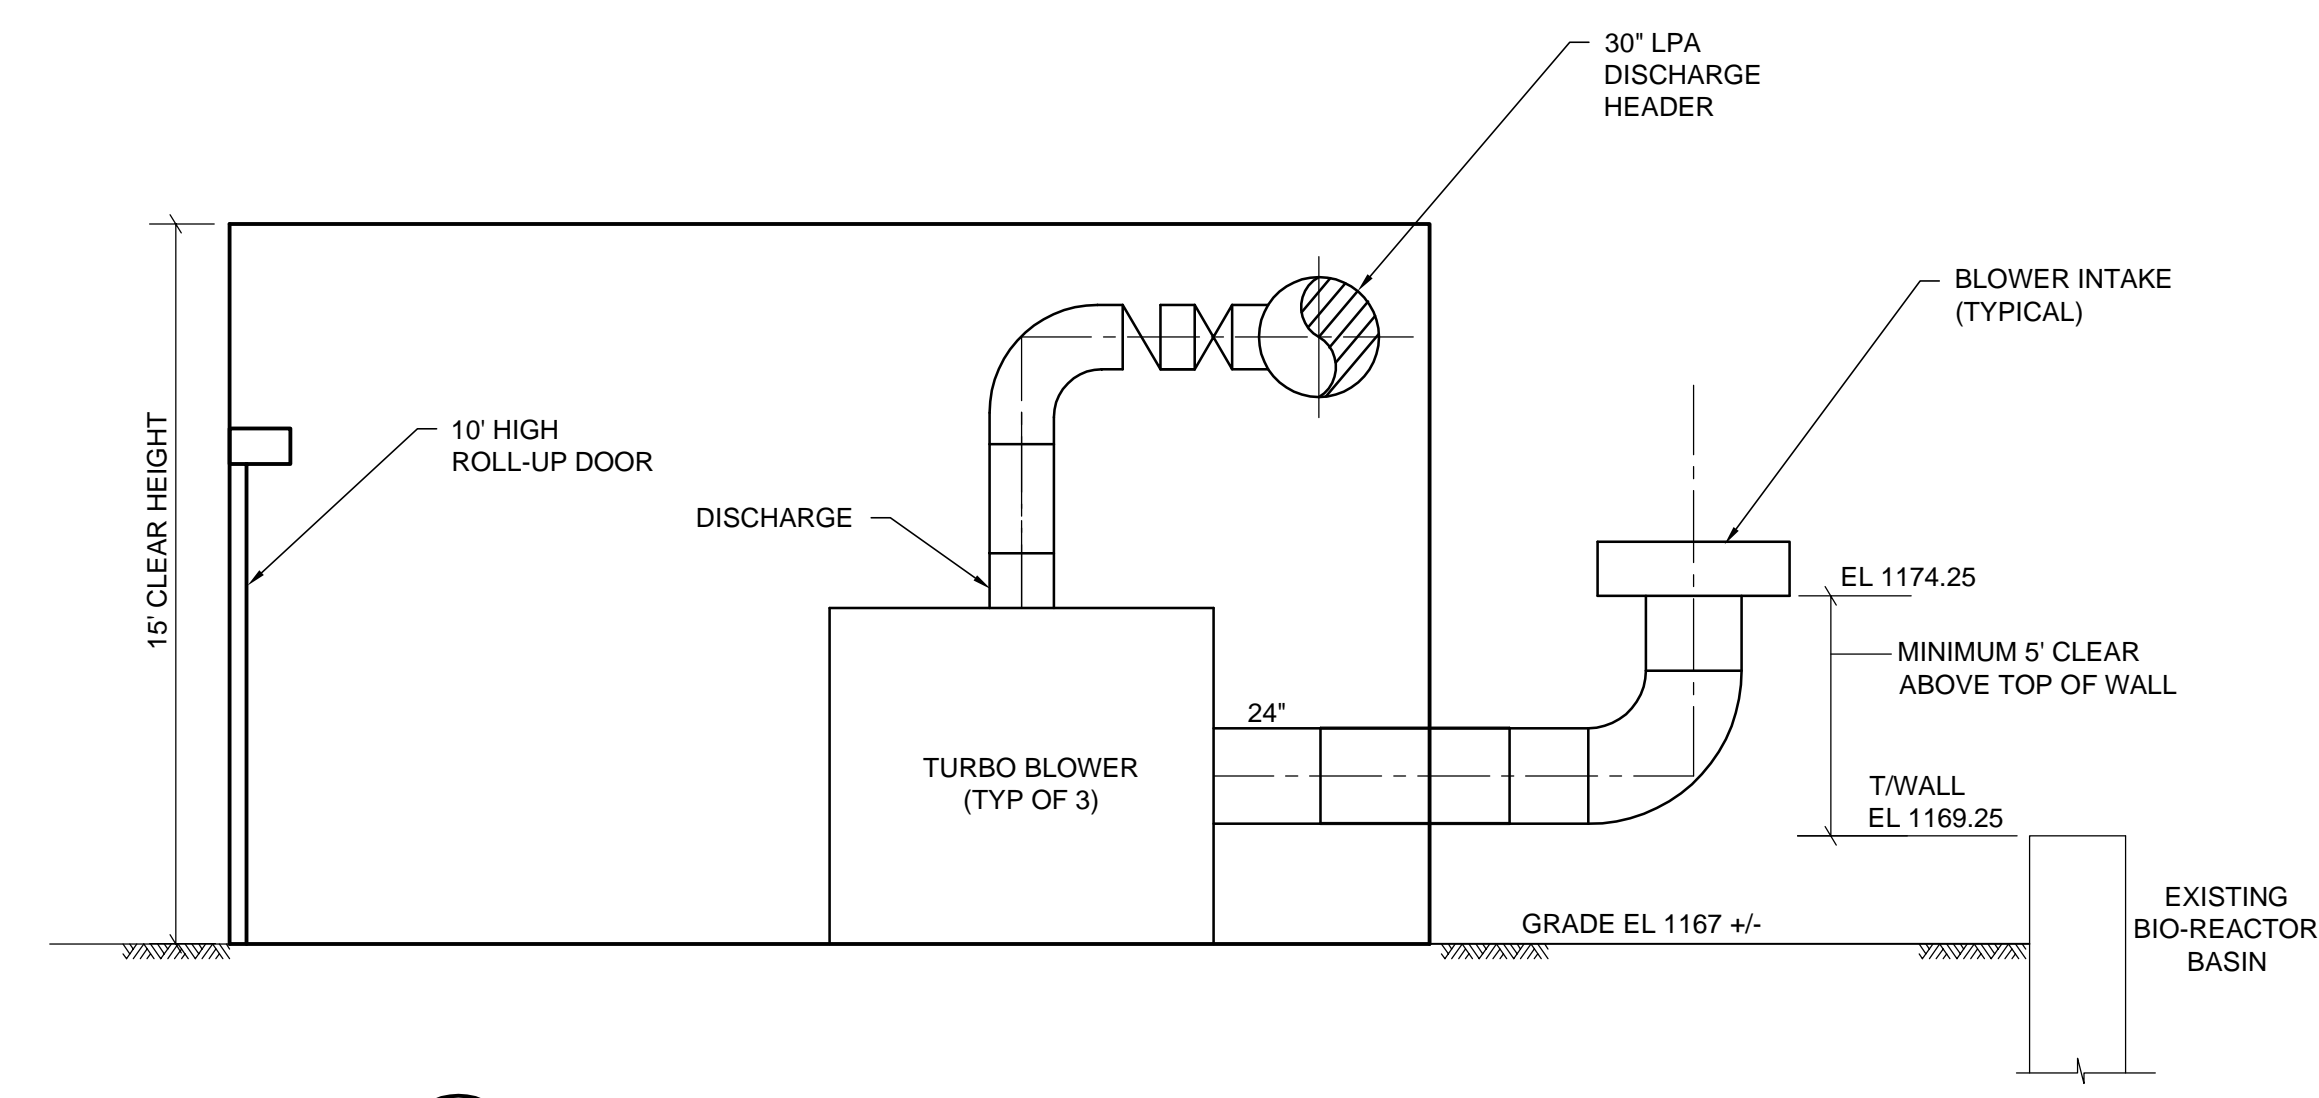

1 SECTION-BLOWER BUILDING
SCALE: 1/4" = 1'-0"

NOT FOR CONSTRUCTION FOR REVIEW ONLY

**HRRSA
NORTH RIVER WWTF
BIOREACTOR BLOWER
EQUIPMENT PROCUREMENT**
MOUNT CRAWFORD, VIRGINIA

MRK	DATE	REVISION DESCRIPTION

COMM NO: 214113.00
DATE: DEC. 11, 2014
DRAWN: JLW DESIGN: AST
CHECK: CRLM

**PRELIMINARY
BLOWER BUILDING
PLAN, SECTION,
AND SITE PLAN**

SHT. NO. **SK-1** REV. NO. **0**